


LABOR OF LOVE FOOD PANTRY

137 COUNTY ROAD, EASTPORT, MAINE

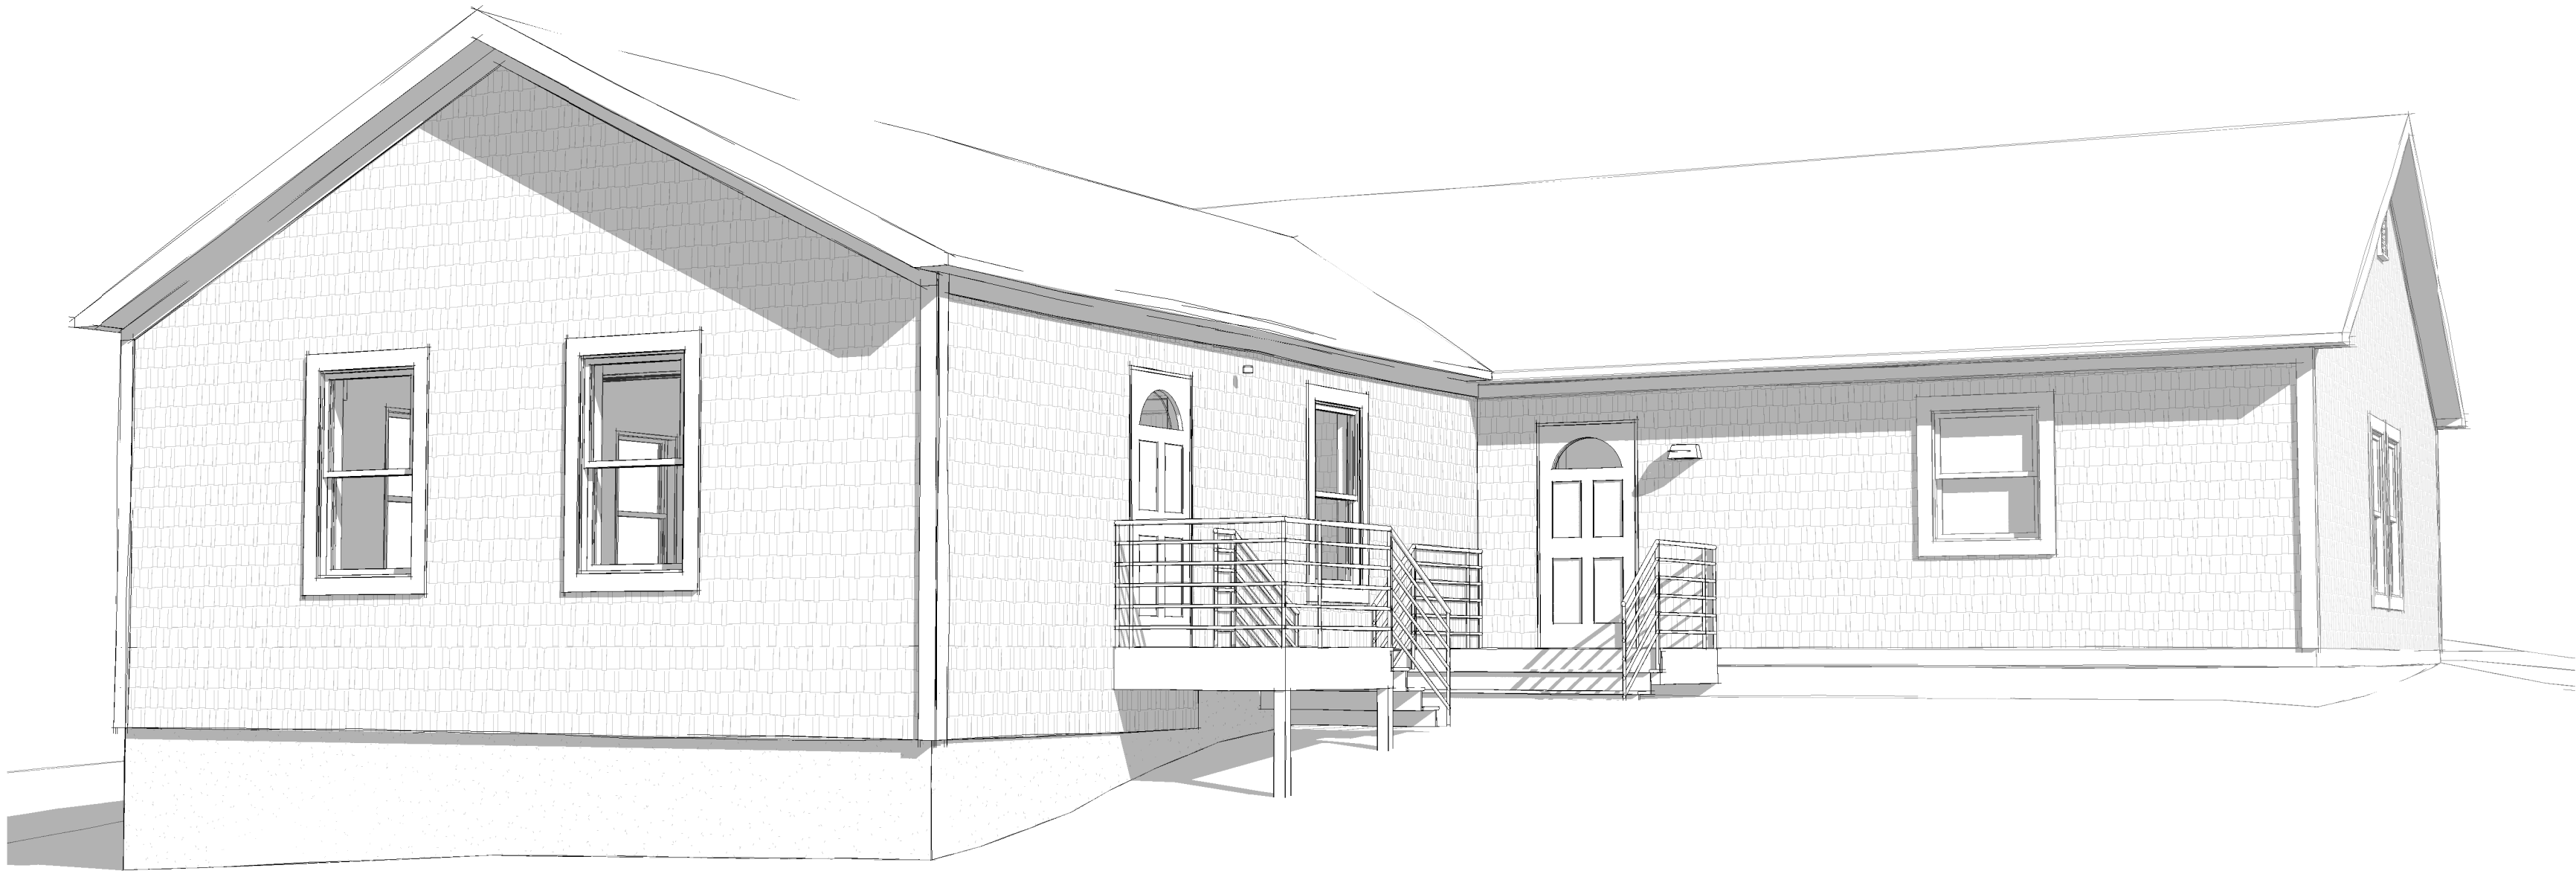

SHEET LIST

G0	COVER
C101	PROPOSED SITE PLAN
S101	FOUNDATION PLAN
S102	ROOF FRAMING PLAN
A100	DEMOLITION PLAN
A101	PROPOSED FLOOR PLAN
A102	PROPOSED ROOF PLAN
A201	EXTERIOR ELEVATIONS & PERSPECTIVE
A202	EXTERIOR ELEVATIONS & PERSPECTIVE
A301	BUILDING SECTIONS
M001	MECHANICAL NOTES, SYMBOLS, ABBREVIATIONS & DETAILS
M101	MECHANICAL PLAN, SCHEDULES AND DETAILS
E001	ABBREVIATIONS, NOTES & SYMBOLS
E101	ELECTRICAL LIGHTING AND POWER & SYSTEMS PLAN
E501	ELECTRICAL ONE-LINE DIAGRAM, DETAILS AND SCHEDULES





ISSUED FOR CONSTRUCTION

2024.05.13



HALEY WARD

ENGINEERING | ENVIRONMENTAL | SURVEYING

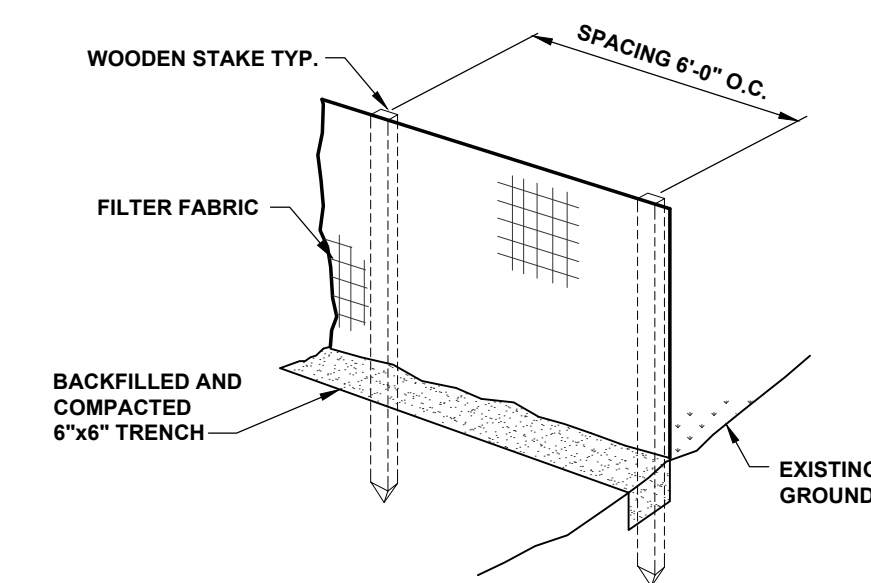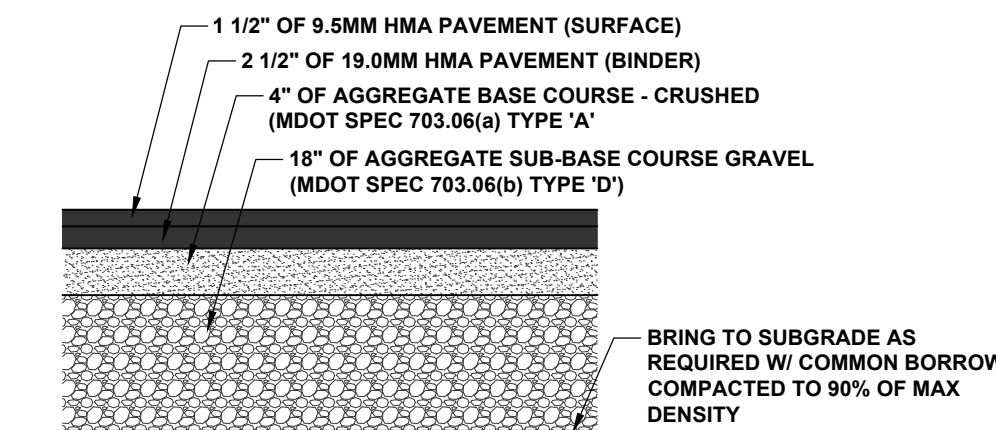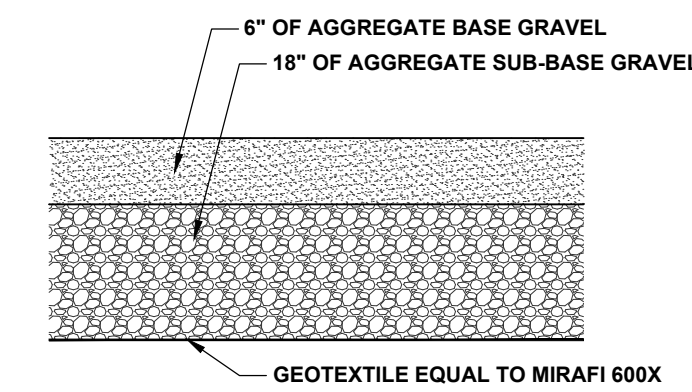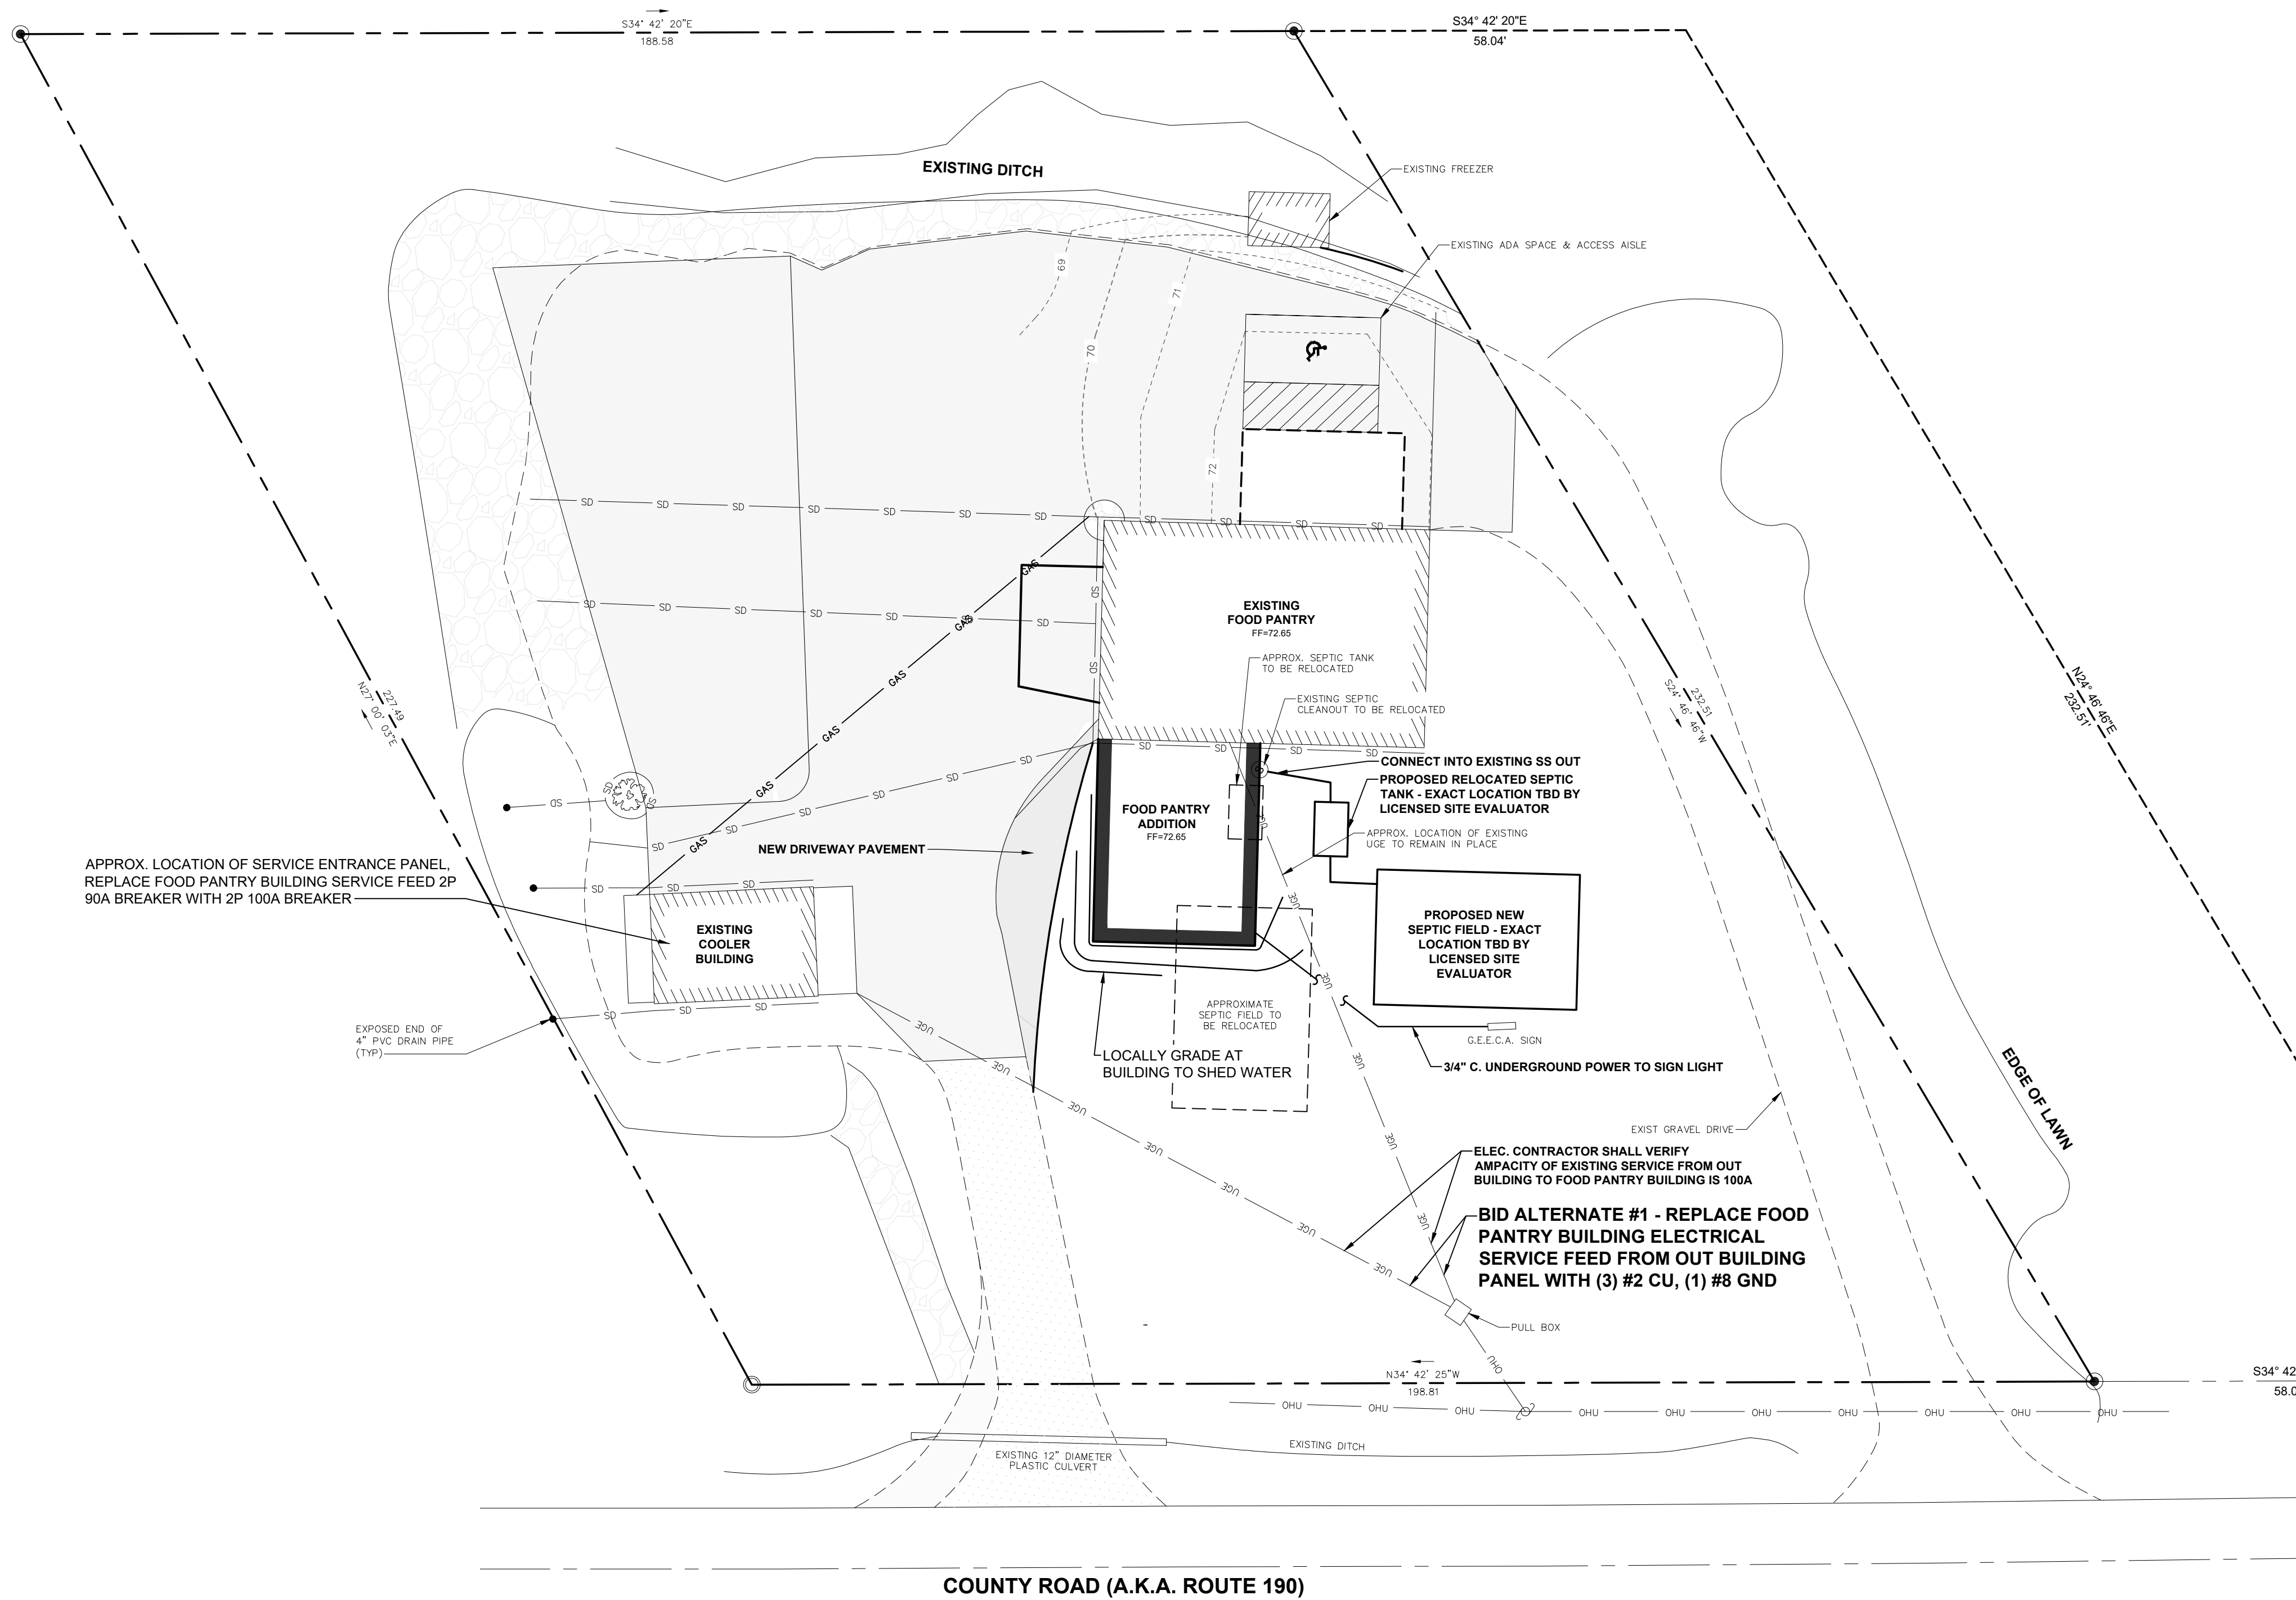

SILT FENCE DETAIL

LEGEND:

PLAN REFERENCE:

REV	DATE	DESCRIPTION	BY	CHK																												
DRAWING ISSUE STATUS																																
ISSUED FOR CONSTRUCTION																																
 HALEY WARD ENGINEERING ENVIRONMENTAL SURVEYING One Merchants Plaza, Suite 701 Bangor, Maine 04401 207.989.4824 WWW.HALEYWARD.COM																																
PROJECT																																
LABOR OF LOVE FOOD PANTRY 137 COUNTY ROAD, EASTPORT, MAINE																																
TITLE																																
PROPOSED SITE PLAN																																
		<table><tr><td colspan="2">DATE</td><td colspan="2">SCALE</td></tr><tr><td colspan="2">2024.05.13</td><td colspan="2">AS NOTED</td></tr><tr><td>DRAWN BY</td><td>DESIGNED BY</td><td colspan="2">CHECKED BY</td></tr><tr><td>JNB</td><td>JNB</td><td colspan="2">CWS</td></tr><tr><td colspan="2">PROJECT No.</td><td colspan="2">13416.001</td></tr><tr><td colspan="2">DRAWING No.</td><td colspan="2">REV</td></tr><tr><td colspan="2">C101</td><td colspan="2"></td></tr></table>			DATE		SCALE		2024.05.13		AS NOTED		DRAWN BY	DESIGNED BY	CHECKED BY		JNB	JNB	CWS		PROJECT No.		13416.001		DRAWING No.		REV		C101			
DATE		SCALE																														
2024.05.13		AS NOTED																														
DRAWN BY	DESIGNED BY	CHECKED BY																														
JNB	JNB	CWS																														
PROJECT No.		13416.001																														
DRAWING No.		REV																														
C101																																